


**Disclaimer:**

The plumbing fixtures that are drawn to comply with owners and/or the builder's specifications and any changes made on them after breaking ground need to be notified to the builder.

WINDOW SCHEDULE				
NUMBER	QTY	FLOOR	SIZE	DESCRIPTION
W02	2	3	1840SH	SINGLE HUNG
W03	14	2	2660SH	SINGLE HUNG
W04	14	3	2660SH	SINGLE HUNG
W06	2	2	2446SH	SINGLE HUNG
W07	2	3	2646SH	SINGLE HUNG
W14	1	3	2446SH	SINGLE HUNG
W16	2	2	3614FX	FIXED GLASS

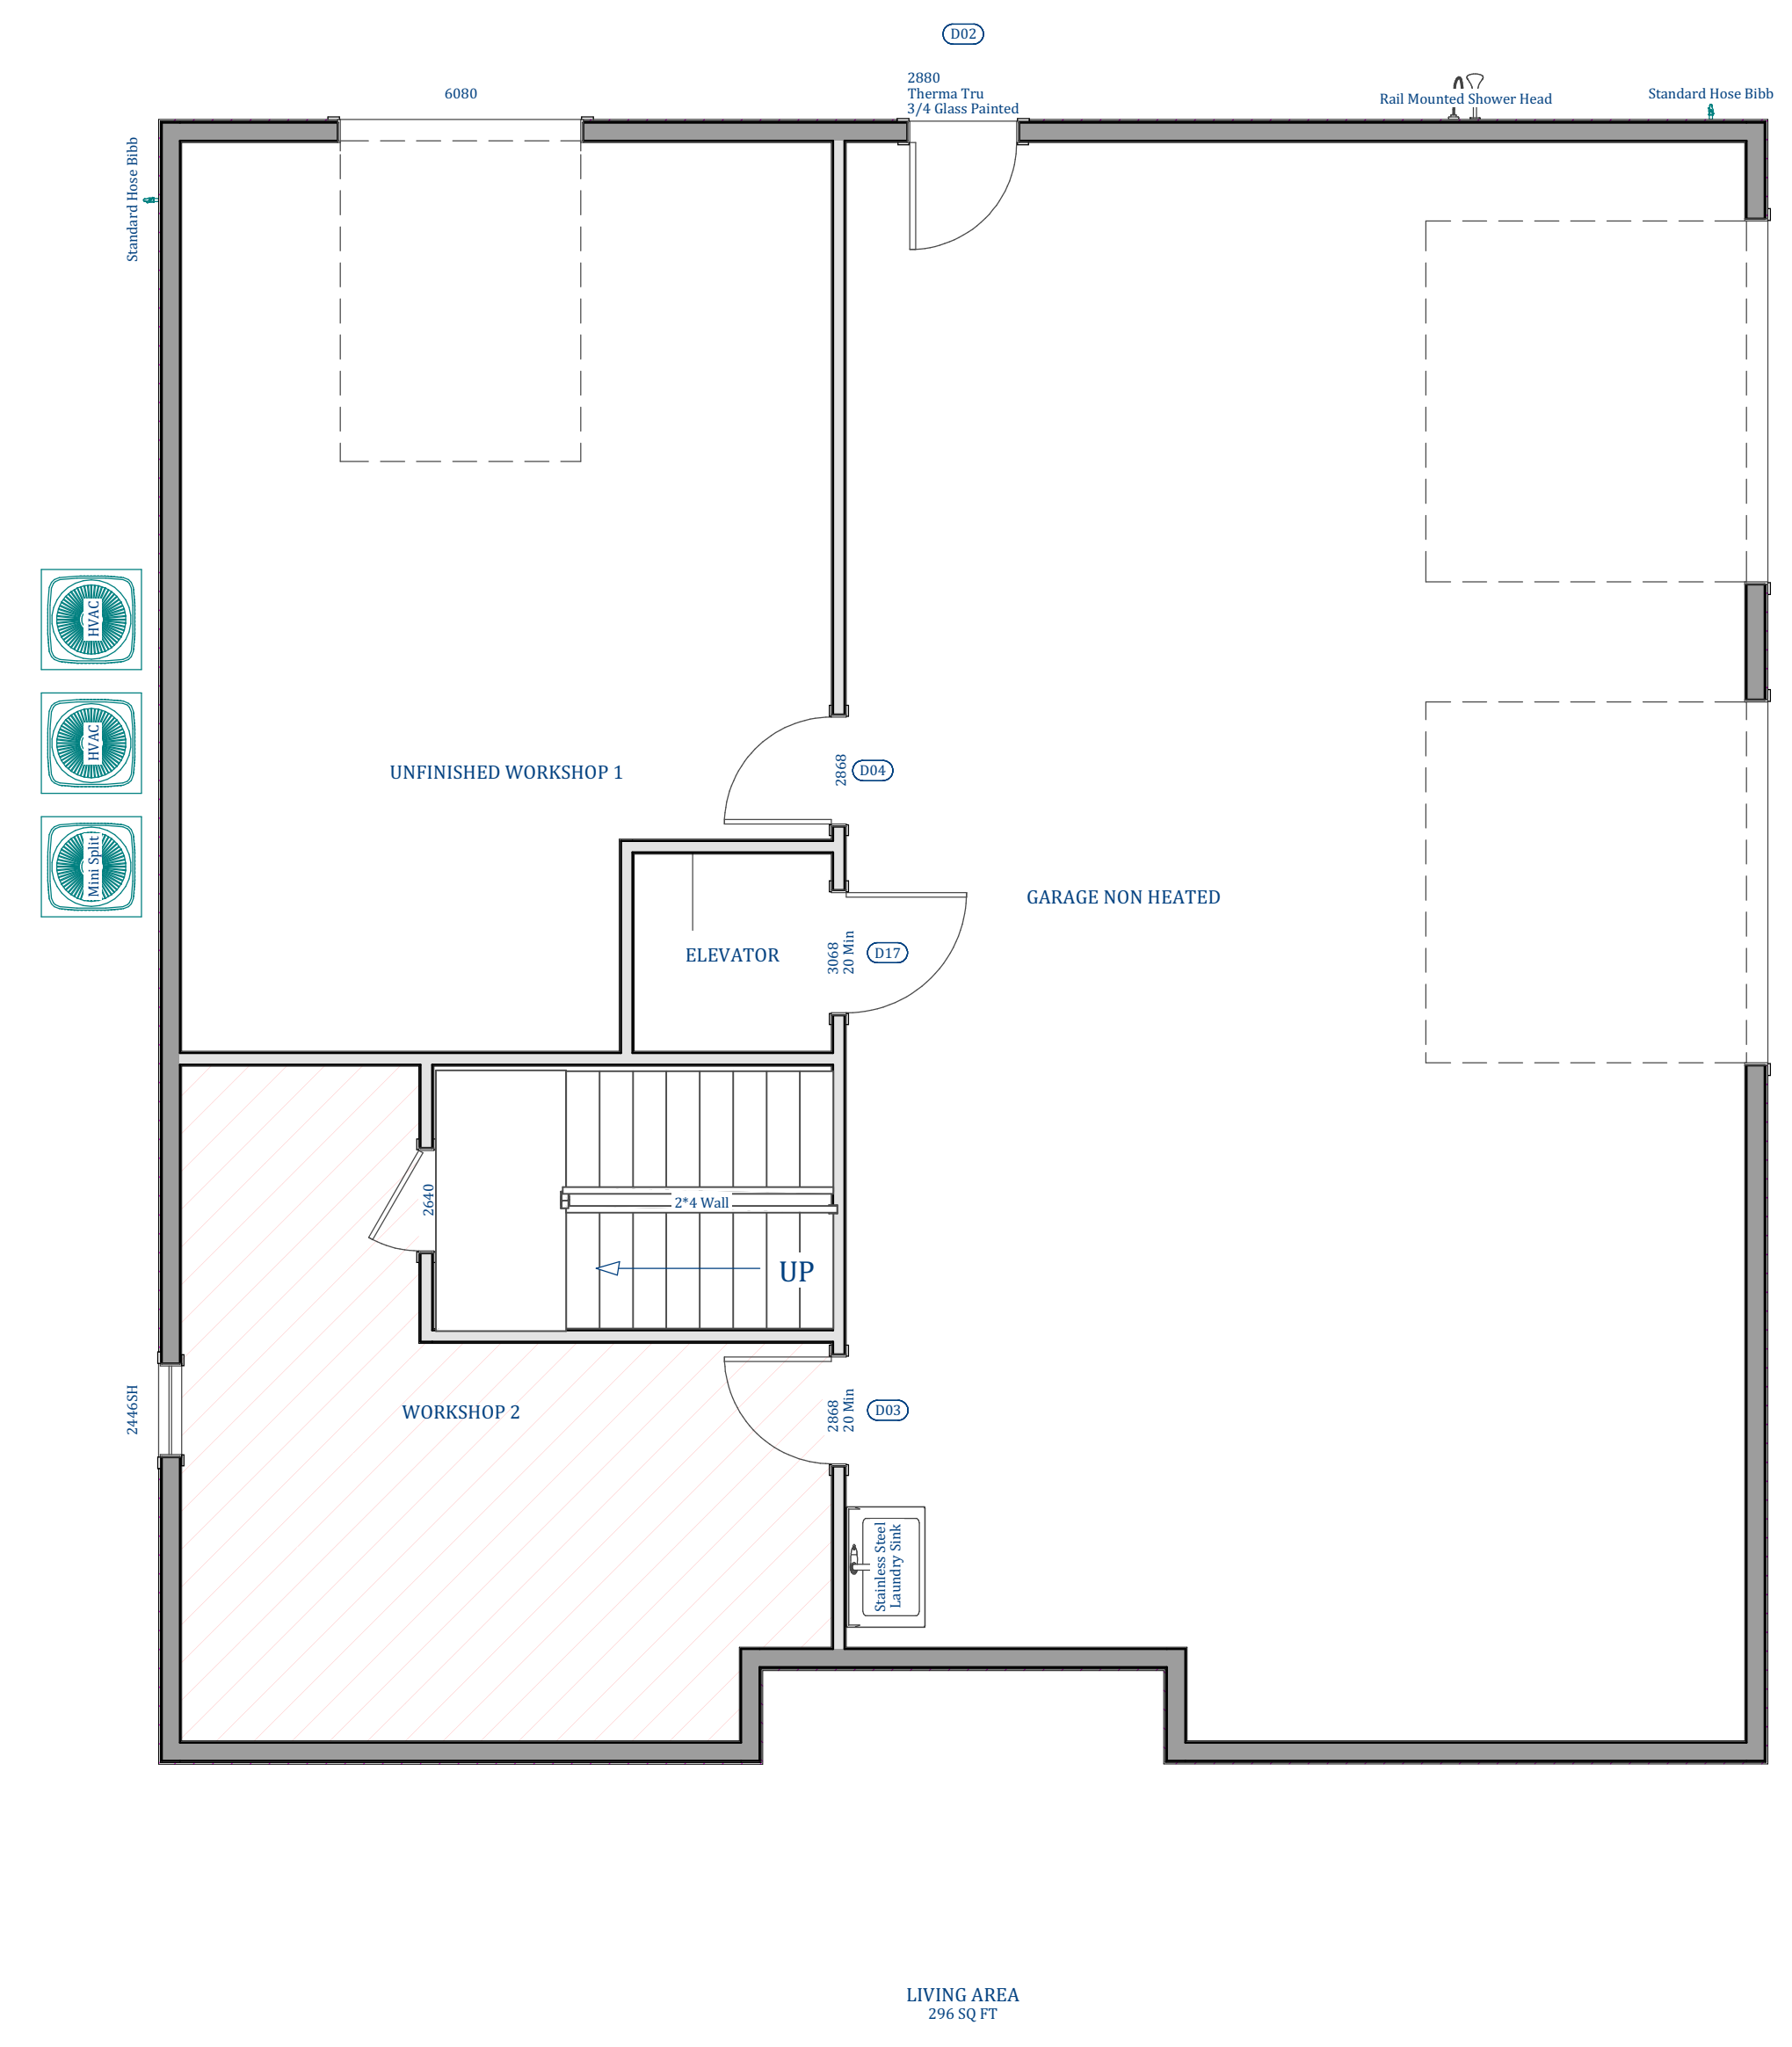

**FIRST FLOOR PLAN**

Scale 1/4" = 1' 0"

REVISION TABLE	
NUMBER	DESCRIPTION

LACE  
PECAN GROVE

FOUNDATION  
& FIRST FLOOR



DATE:

6/14/2024

SCALE:


1/4" = 1'

SHEET:

A-5

# SECOND FLOOR PLAN

Scale 1/4" = 1' 0"

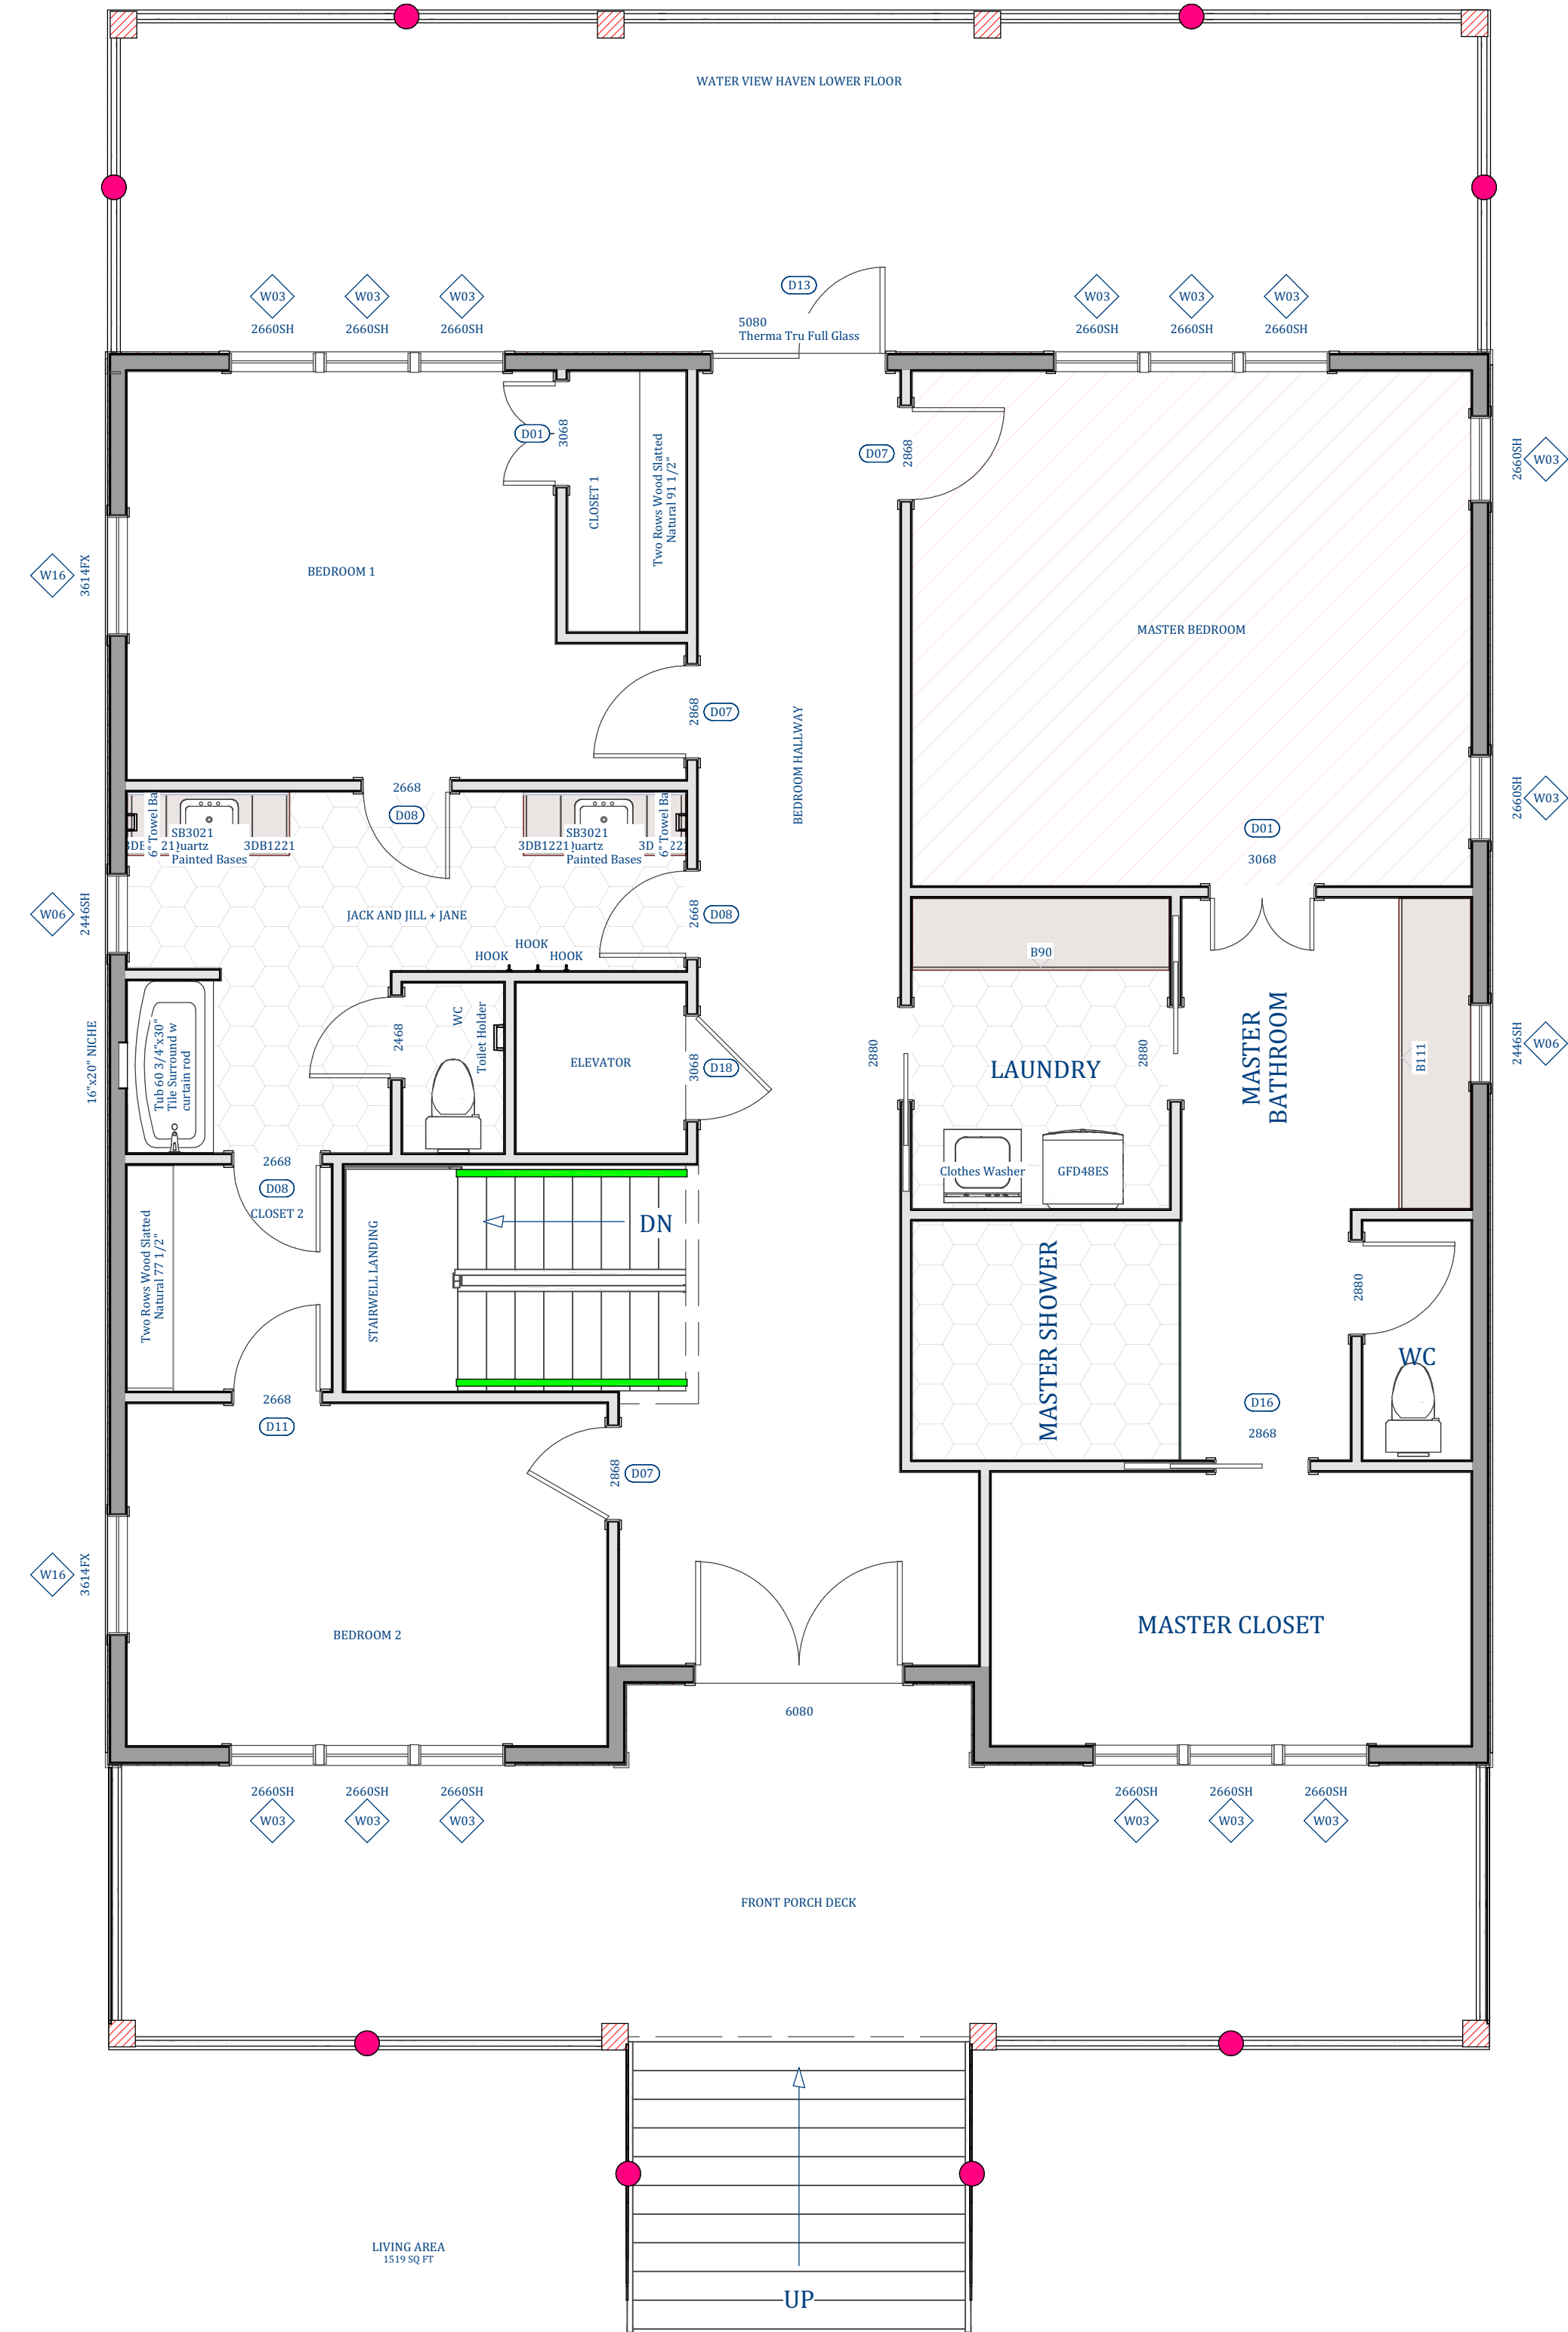

# THIRD FLOOR PLAN

Scale 1/4" = 1' 0"



WINDOW SCHEDULE				
NUMBER	QTY	FLOOR	SIZE	DESCRIPTION
W02	2	3	1840SH	SINGLE HUNG
W03	14	2	2660SH	SINGLE HUNG
W04	14	3	2660SH	SINGLE HUNG
W06	2	2	2446SH	SINGLE HUNG
W07	2	3	2646SH	SINGLE HUNG
W14	1	3	2446SH	SINGLE HUNG
W16	12	2	3614FX	FIXED GLASS

REVISION TABLE	
NUMBER	DATE / REVISION BY / DESCRIPTION

## LACE PECAN GROVE

## SECOND AND THIRD FLOOR

LONGSHORE CUSTOM HOMES



DATE:

6/14/2024

SCALE:

1/4" = 1'

SHEET:

A-6